


PROPOSED REVISION OF ROADS, PATHS, BUILDINGS, ENCLOSURES & PARKING AREAS IN THE VICINITY OF WASHINGTON'S HEADQUARTERS AT VALLEY FORGE PARK

SCALE 1"=30'

PREPARED FOR THE VALLEY FORGE PARK COMMISSION

*R. S. Burns,
Landscape Architect
7/18/26.*

NOTES:
PROPOSED PARKING SPACE WILL ACCOMMODATE 110 AUTOMOBILES.
BUILDINGS SHOWN ARE EXISTING AND CAN BE REMODELED FOR PURPOSES INDICATED.
ADDITIONS TO CENTRAL HEATING PLANT IN SUPT. QUARTERS WILL PROVIDE FOR OTHER
STRUCTURES.
FENCE LINES AND PATHS ABOUT WASHINGTON'S HEADQUARTERS ARE DERIVED AT FROM
OLD PHOTOGRAPHS AND FROM DEDUCTION.
DASHED LINES INDICATE EXISTING FEATURES.
DOTTED LINES INDICATE PARKING PLOTS.
IF DESIRED TO LET CONTRACTS FOR EXECUTION OF WORK, SUPPLEMENTARY DRAWINGS
FROM AN ACCURATE TOPOGRAPHICAL SURVEY WILL BE NEEDED.

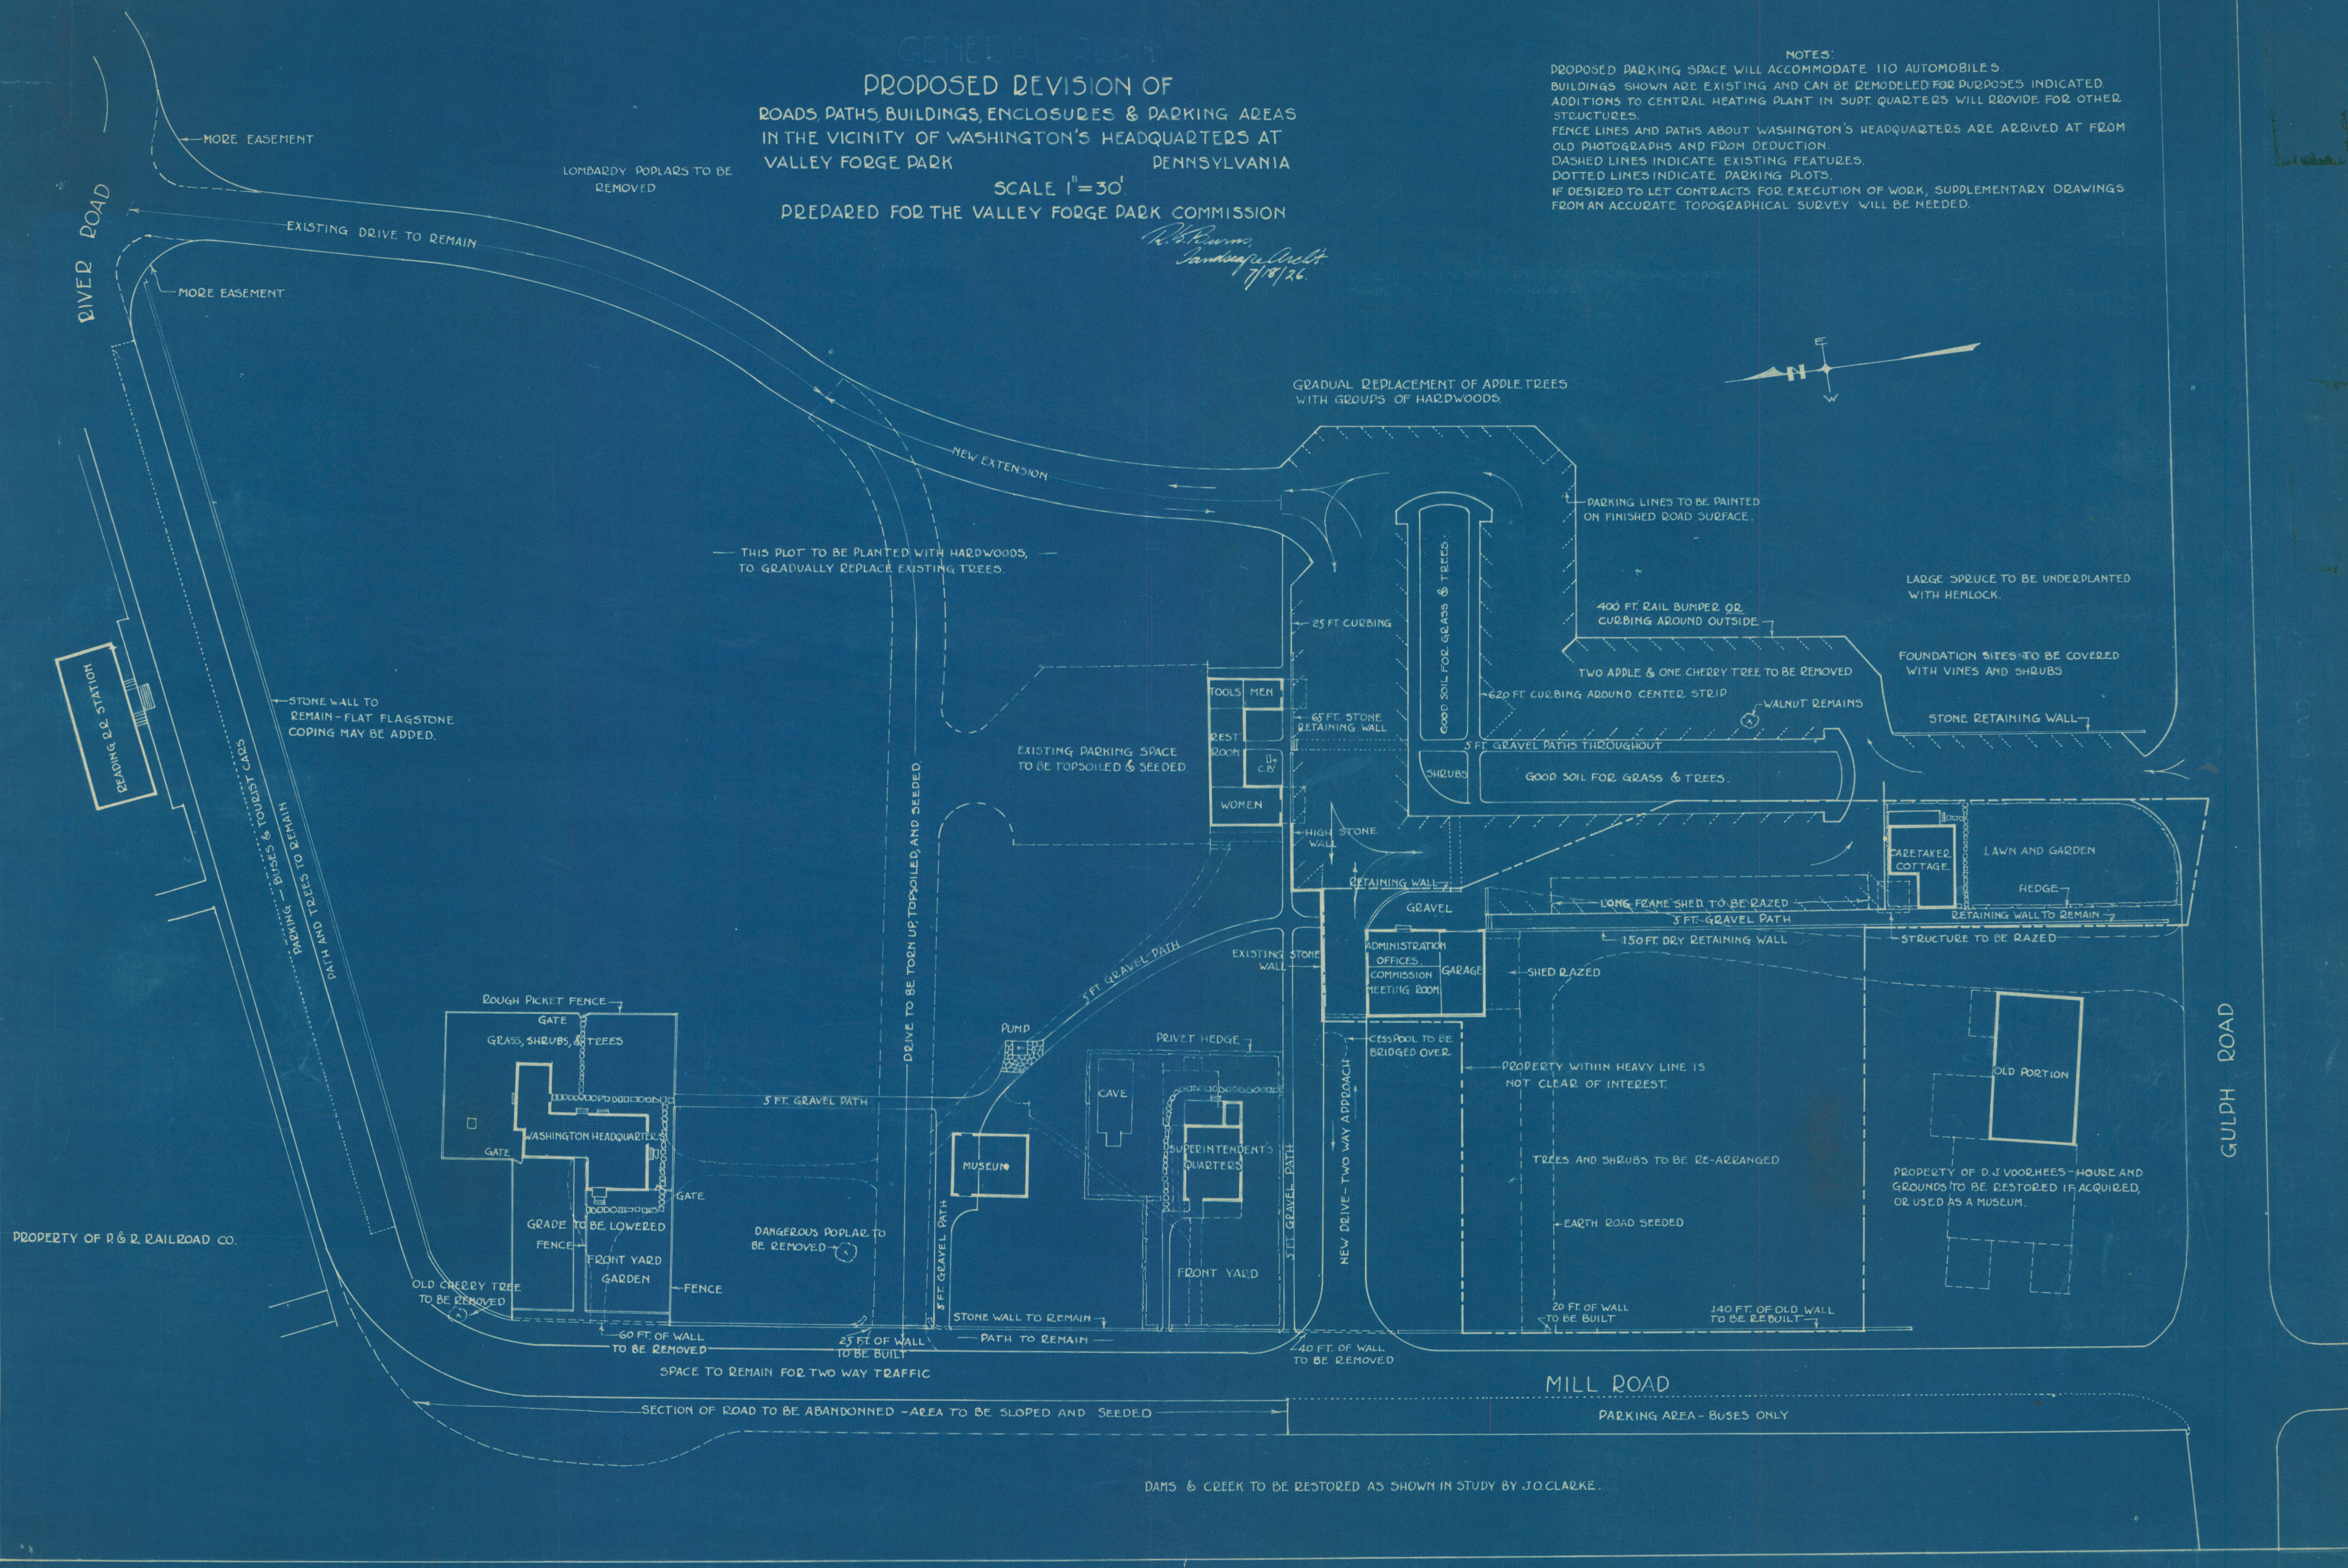

DAMS & CREEK TO BE RESTORED AS SHOWN IN STUDY BY JO CLARKE.